



NOTES:  
 - Temperatures illustrate 1 hr  
 - No references on project

Luminaire Schedule	Label	Arrangement	Total Lamp Lumens	Luminaire Lumens	LLF	Description
3	S124	SINGLE	N/A	8521	0.912	McGraw-Edison, GLEDV-AE-02-LED-E1-S14-HSS

Calculation Summary	CalcType	Units	Avg	Max	Min	Avg/Min	Max/Min	Description
Parking Lot	Illuminance	Fc	2.18	3.3	0.4	5.45	8.25	8'x8' Grid A/U AFF
Property Line	Illuminance	Fc	0.42	0.9	0.0	N/A	N/A	8' Spacing Along Line At 0' AFF

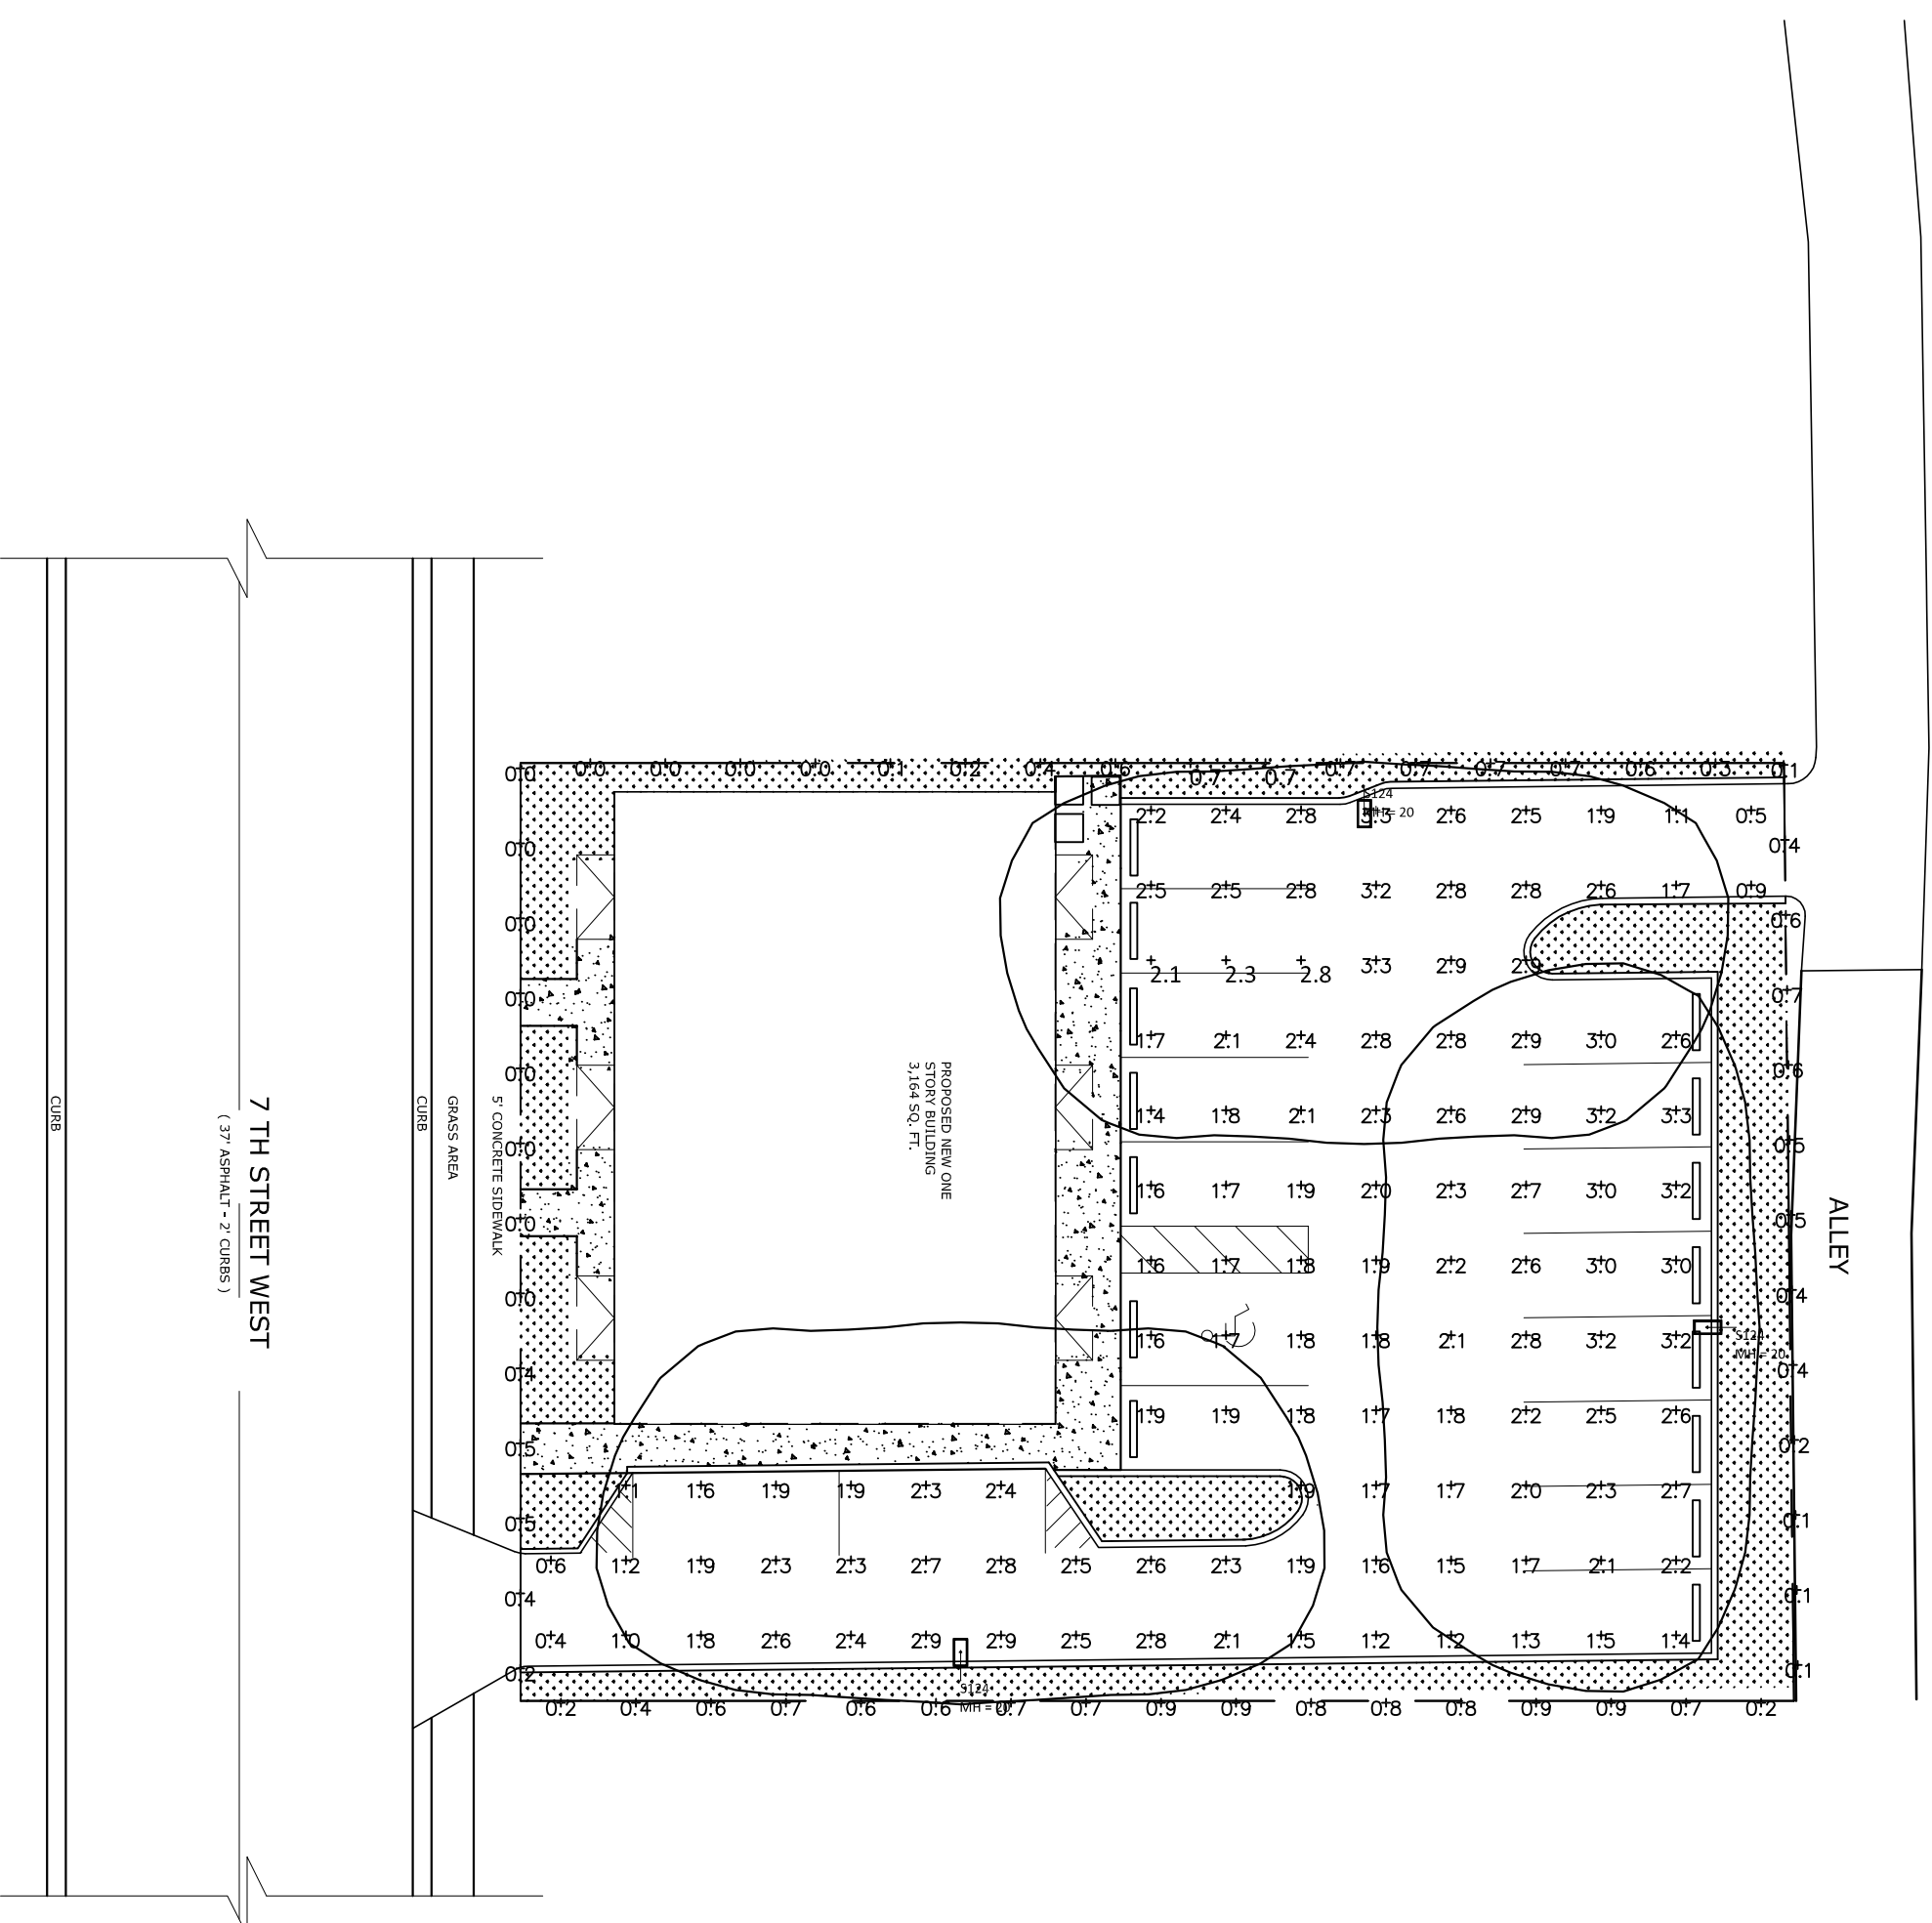


**SITE LIGHTING PLAN**  
 SCALE : 1" = 20'-0"

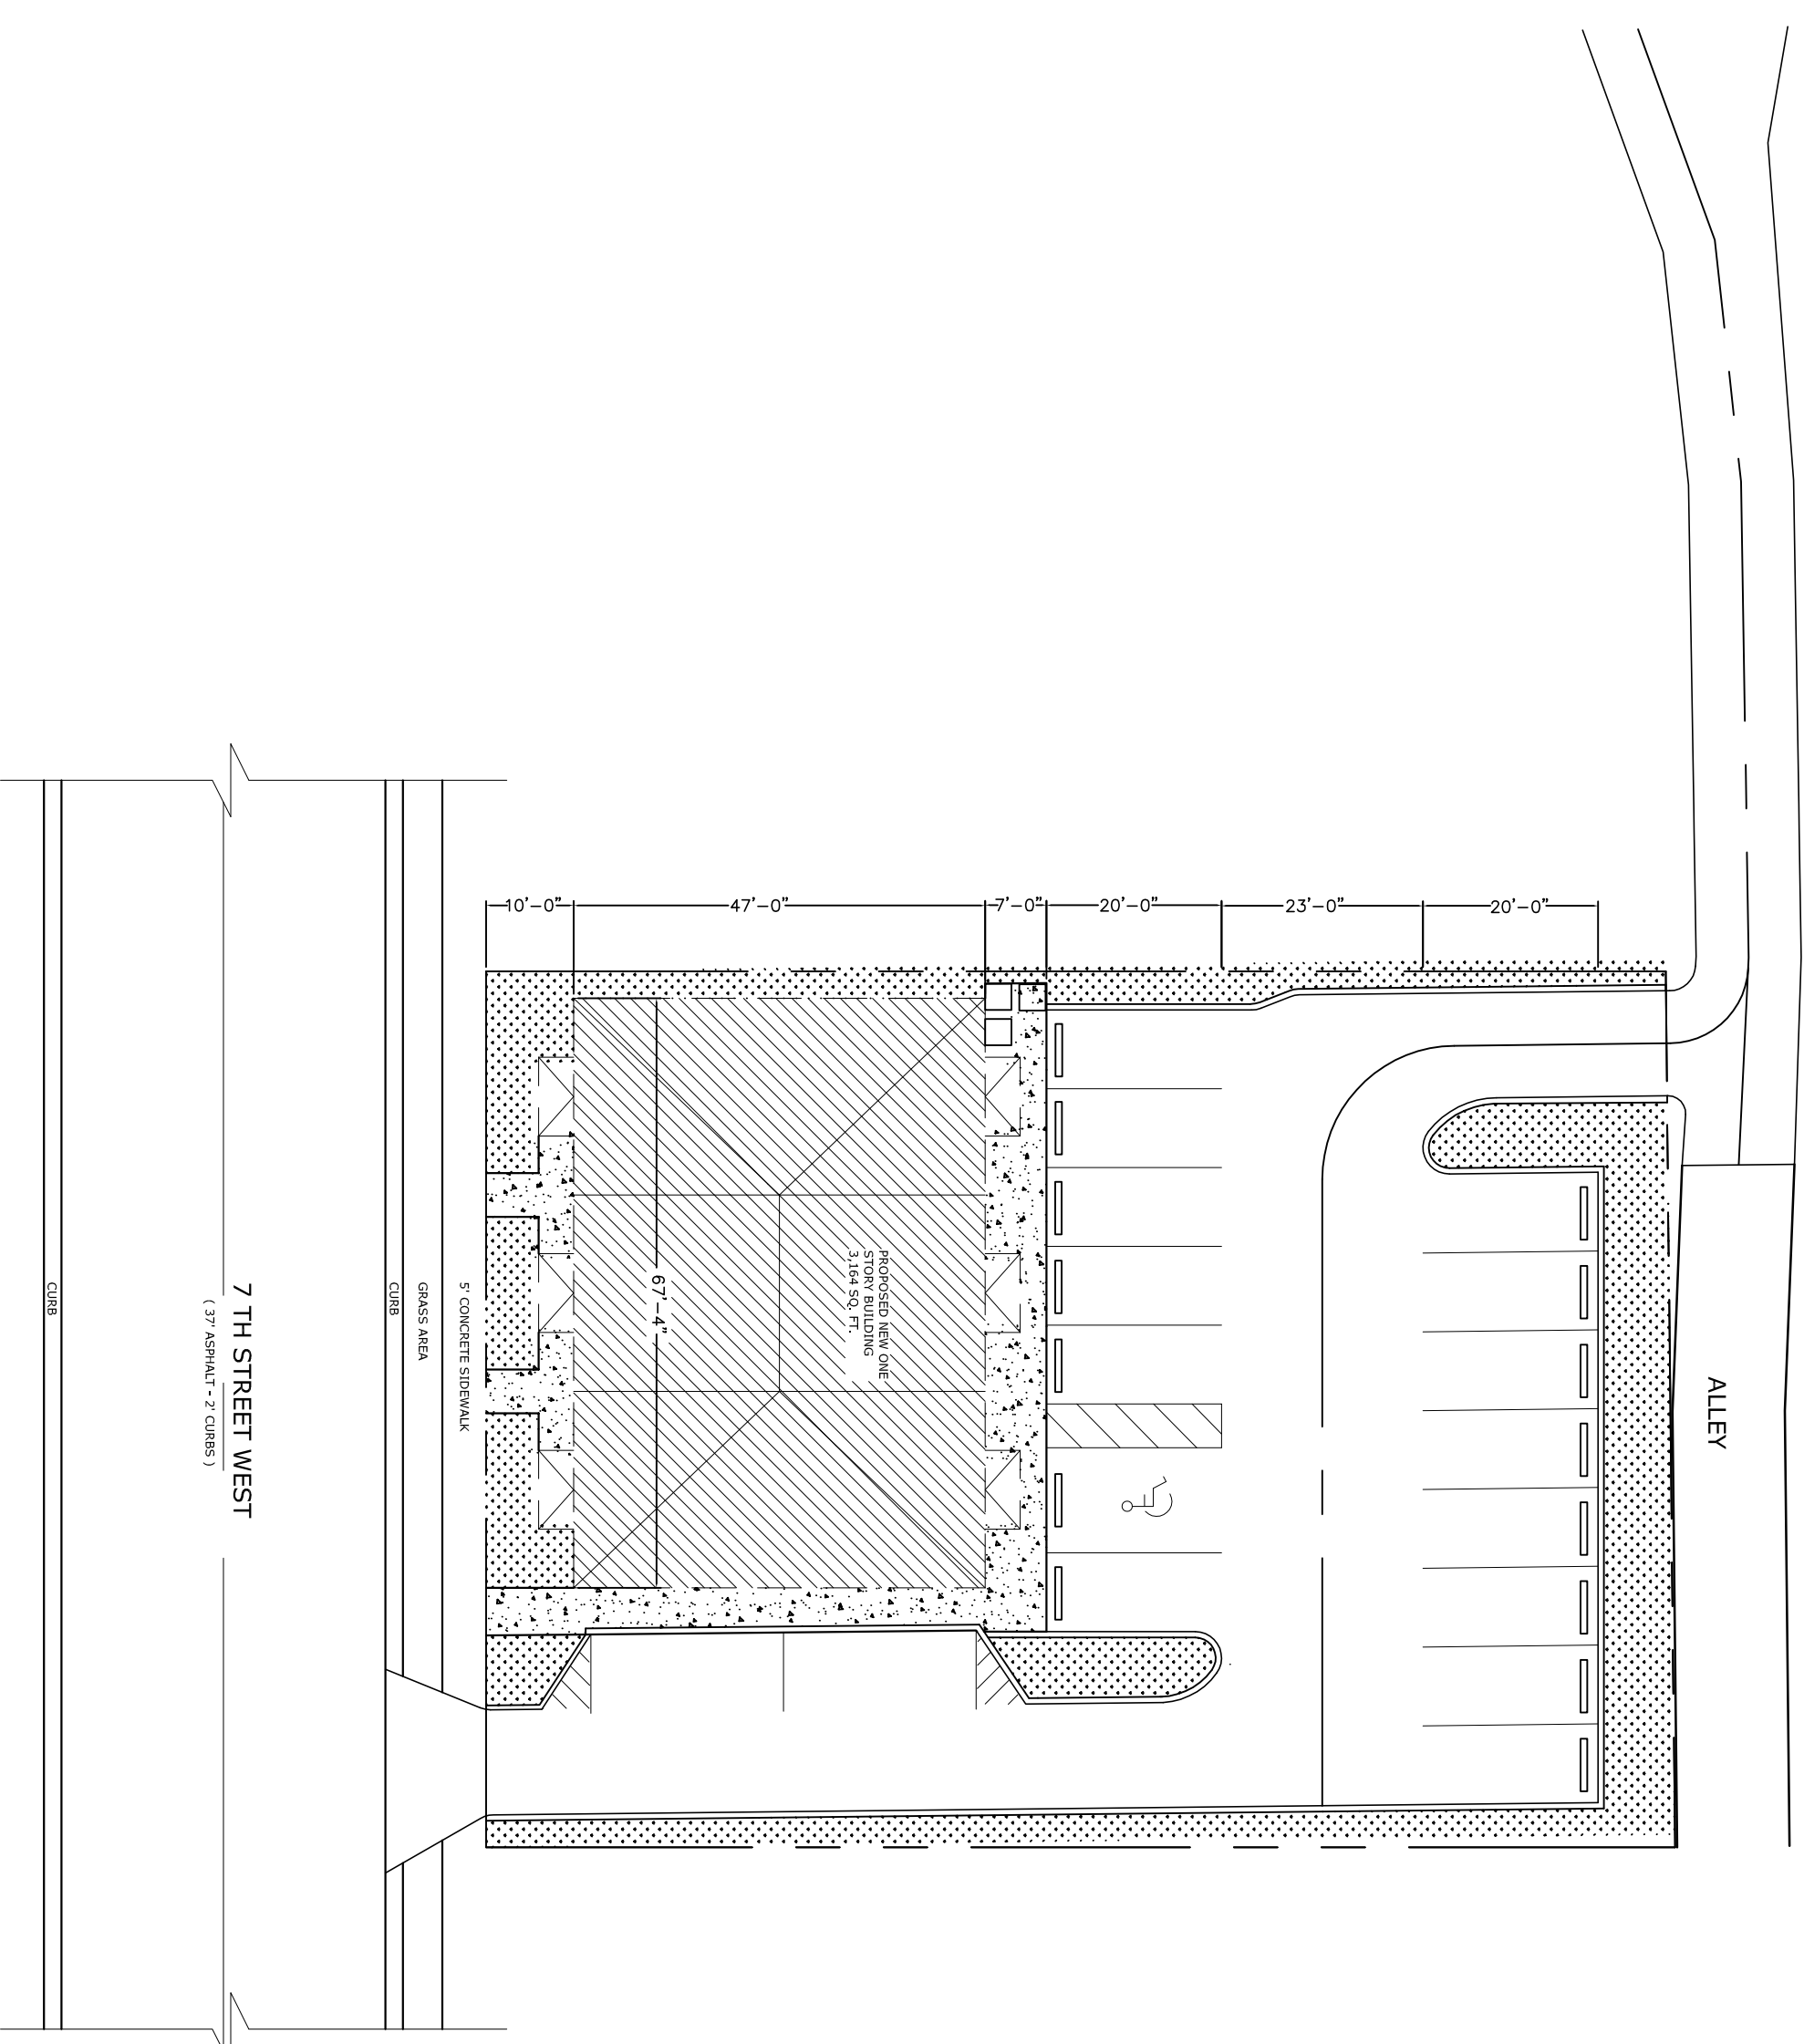

**ARCHITECTURAL SITE PLAN**  
 SCALE : 1" = 20'-0"

NOTE: SEE CIVIL ENGINEERING DRAWINGS FOR ALL SITE RELATED CONSTRUCTION AND LANDSCAPE DETAILS.

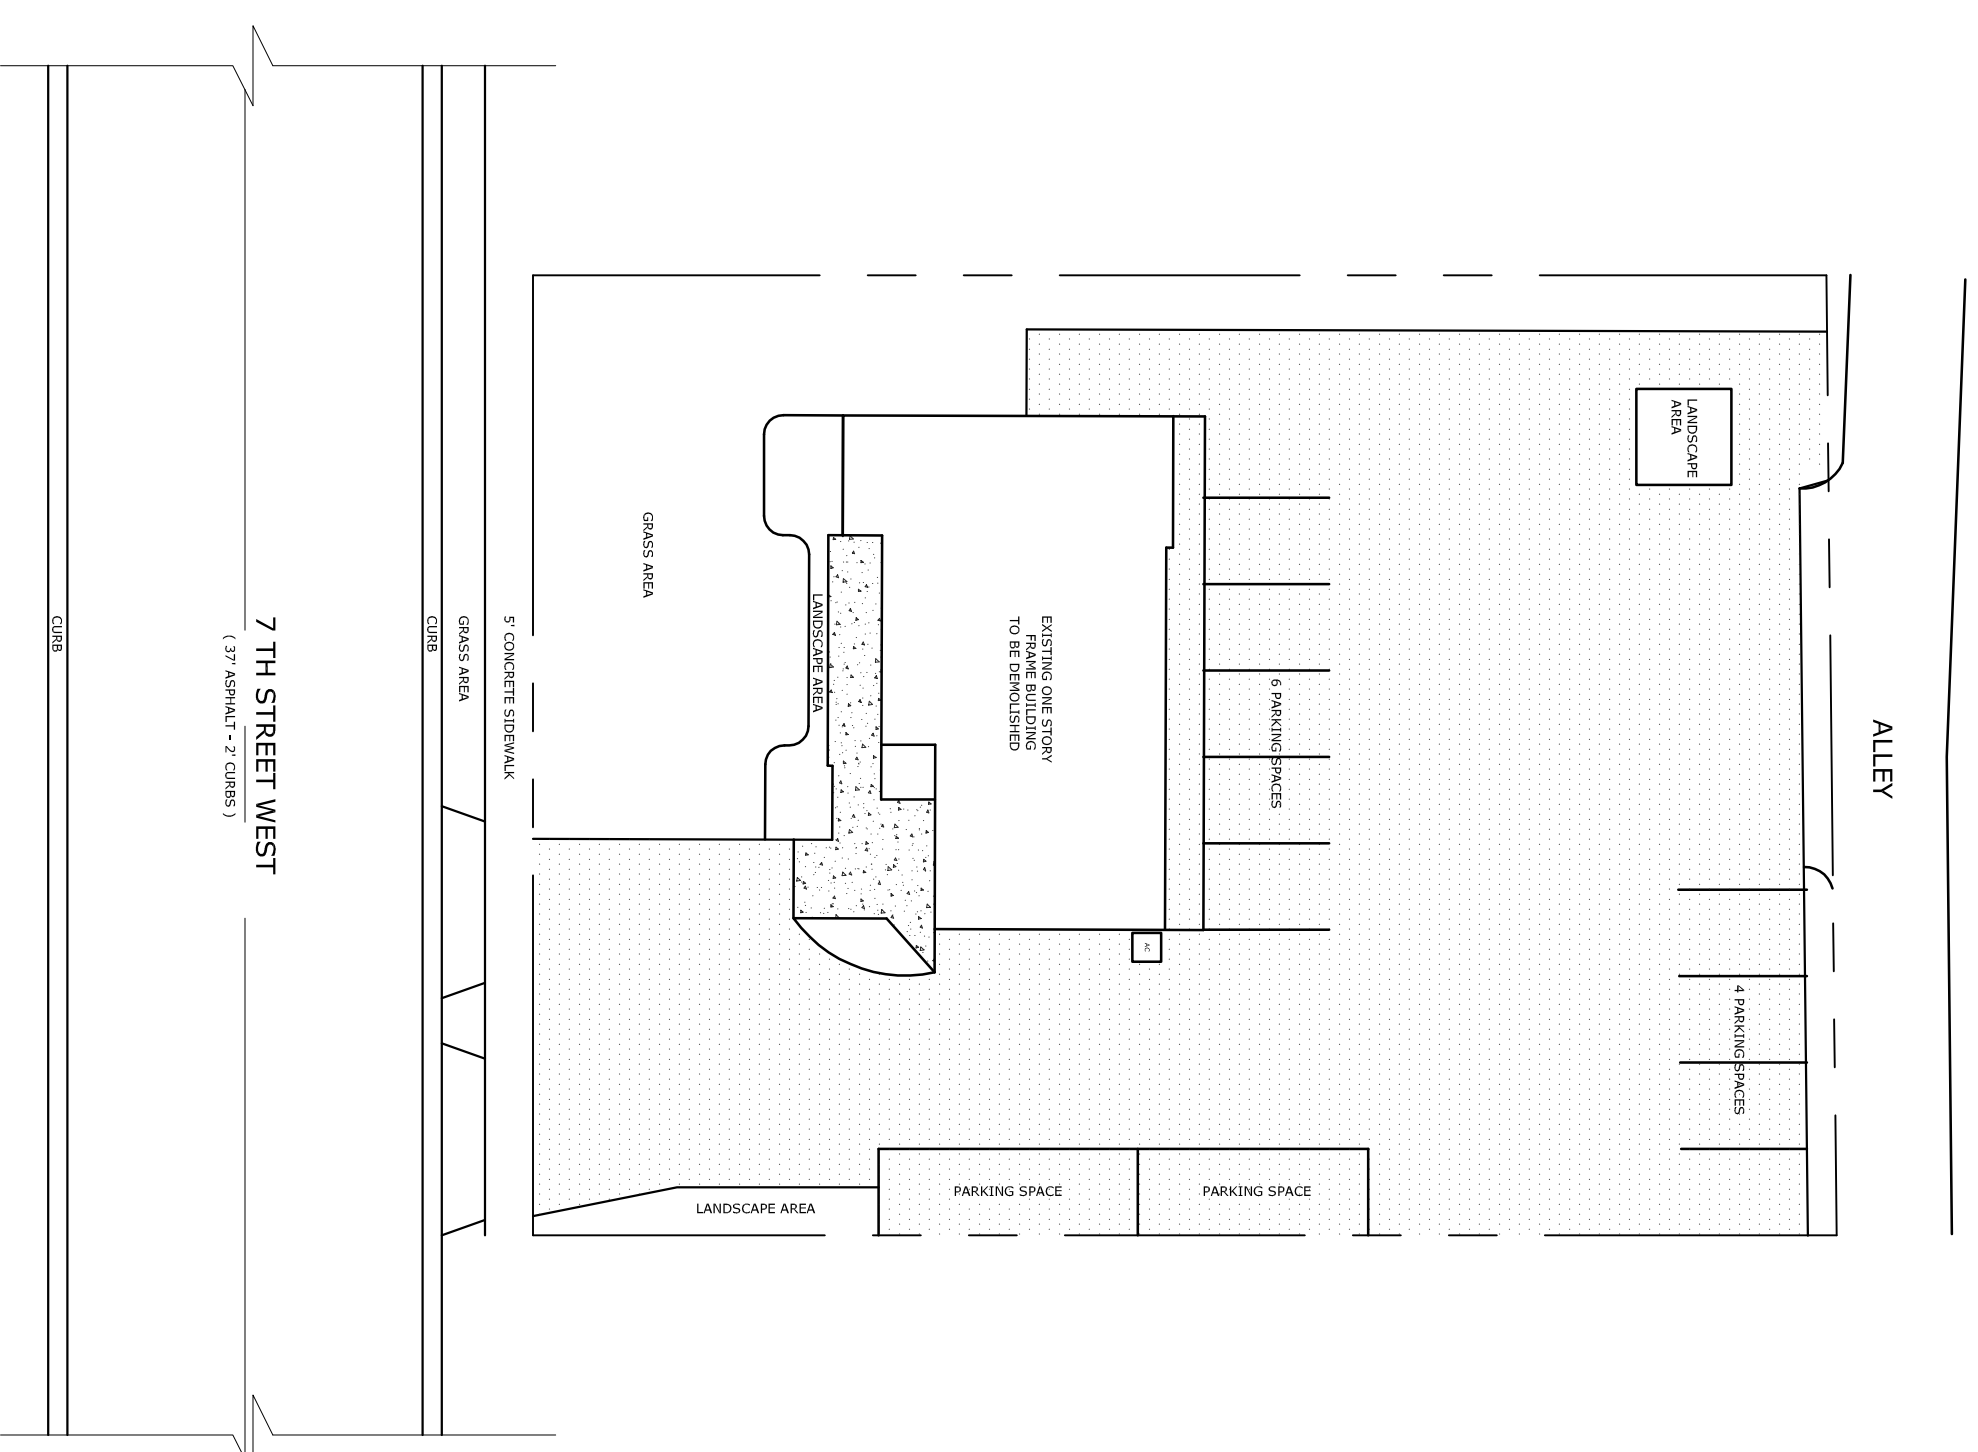

**EXISTING SITE PLAN**  
 SCALE : 1" = 20'-0"




WORLD DESIGN, INC.  
 4301 32nd Street West, Suite D-5  
 Bradenton, Florida 34205  
 NCARB CERTIFIED (941)-755-3934  
 FAX (941)-756-6869  
 FL AAC001570 EB 0007666 SC B88014  
 John A. Ziemnicki, A.I.A.  
 FL 12518 SC 3558 IL 11783 TN 23111

REVISIONS
△
△
△
△

FILE :
© COPYRIGHT 2014 WORLD DESIGN, INC.

NEW BUILDING FOR:  
**CONSTANTINE CHIROPRACTIC**  
 312 7TH STREET WEST  
 PALMETTO, FLORIDA

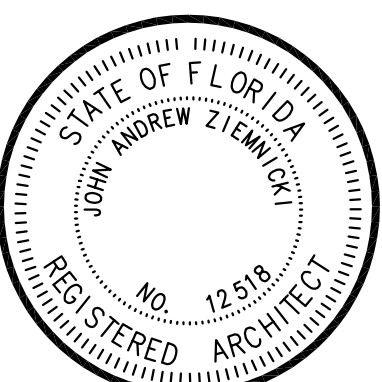

Job No. 13-19  
 Date 4-28-14  
 Sheet No.  
**C-1**  
 of 1