



ELECTRICAL LEGEND

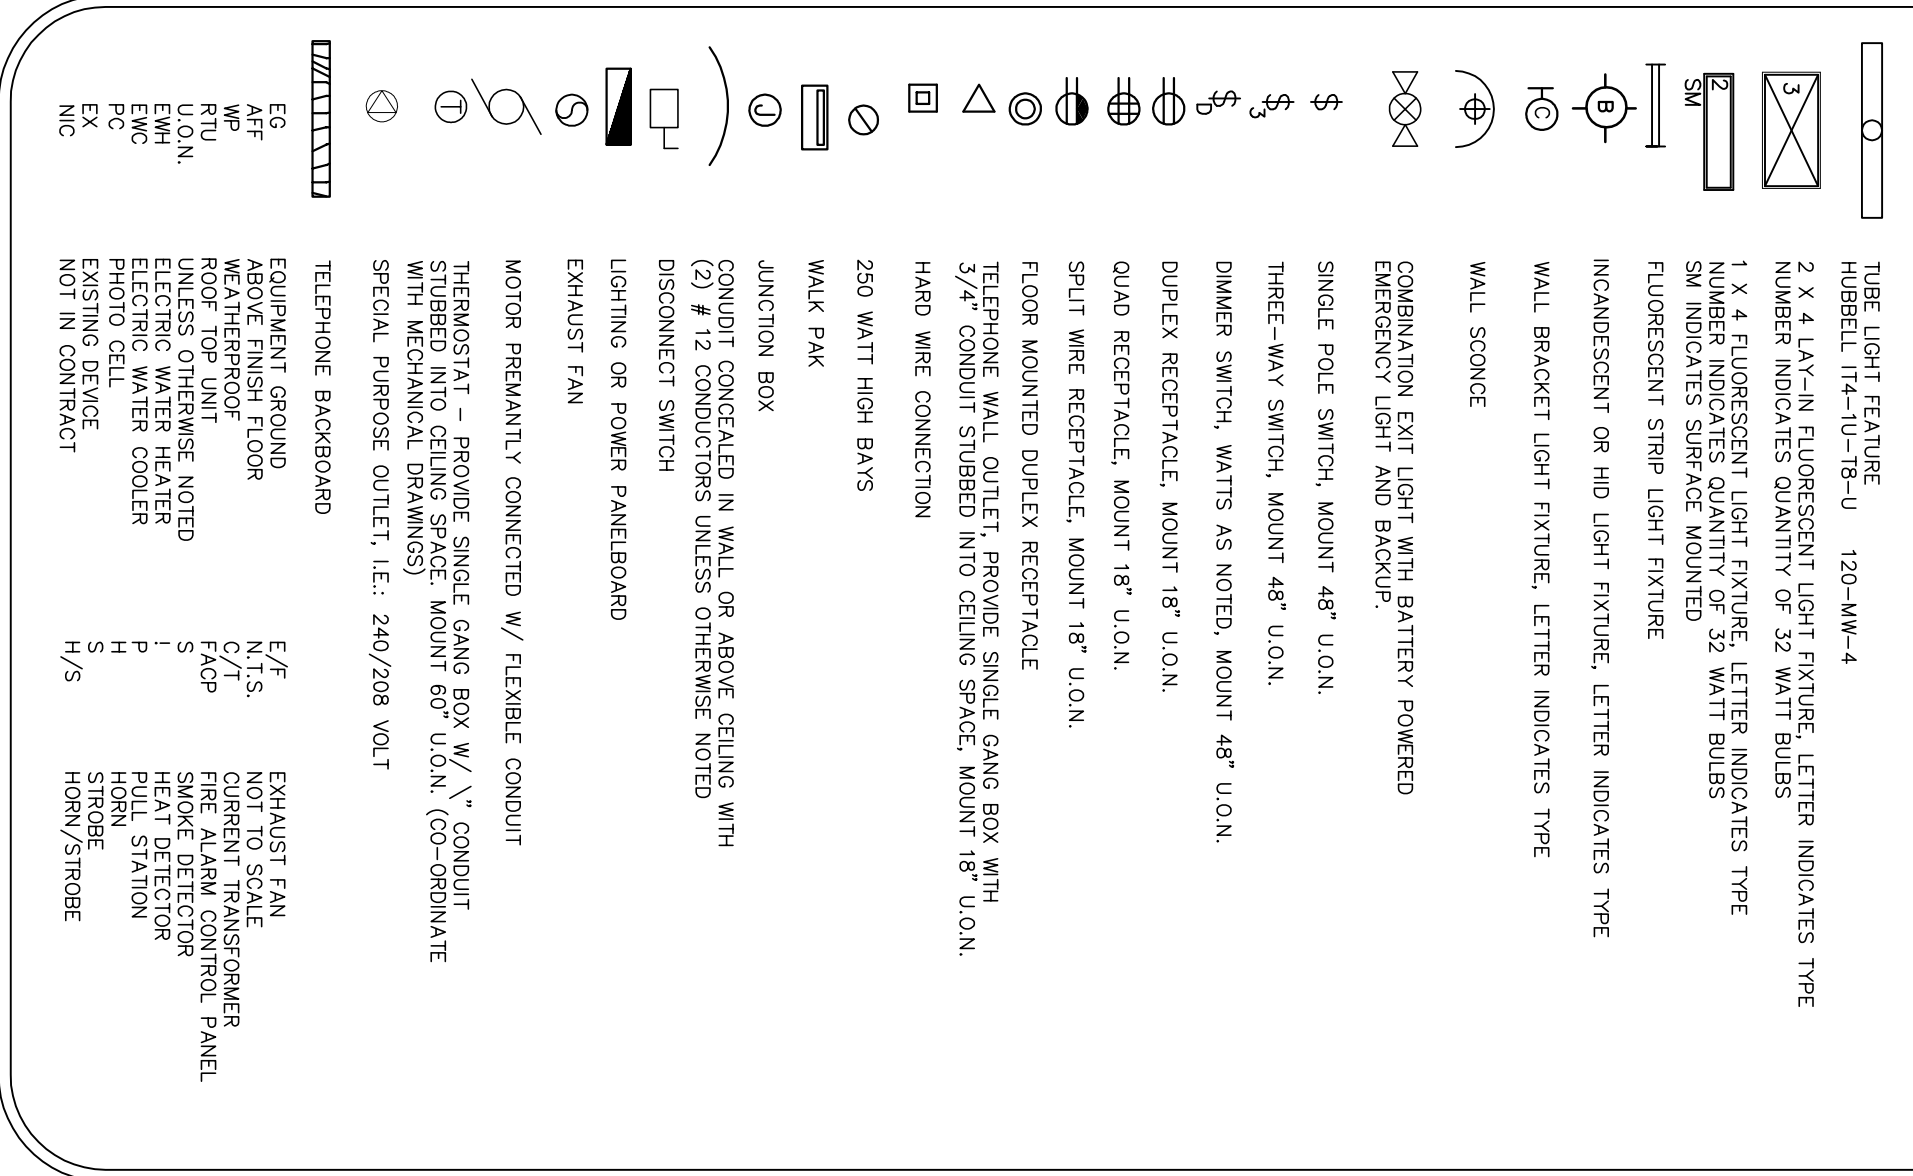

ELECTRICAL FIXTURES


- PORCH SOFFIT LIGHTING (6) RECD.**
PHILIPS FOR INO LED MODULE
SPRINGER-130K-1308011-WHT
LSER24-30MLG-C-EU
(30) 2' X 4' LED LAY-IN TROFFERS COLUMBIA LIGHTING
LAWZ-35LW-EU
(2) 1' X 4' LED RESTROOM FIXTURES COLUMBIA LIGHTING
LRO4-35LW-EU
(2) 1' X 4' LED MECH ROOM FIXTURES COLUMBIA LIGHTING
LRO4-35LW-EU
(1) 1' X 4' LED STO ROOM FIXTURE COLUMBIA LIGHTING
LRO4-35LW-EU
(3) PARKING LOT POLE FIXTURES MCGRAW-EDISON
GLEON-AE-02-LED-E1-SL4-HSS

LIGHTING CONTROL SPECIFICATIONS
BATHROOMS
 ONW-D-1000-D-MV-W (WHITE DULA RELAY FOR LIGHT & FAN)
TREATMENT ROOMS/OFFICES
 ONW-D-1000-D-MV-W
CORRIDORS
 OAC-DT-0501 /SP20-MV
RECEPTION
 OAC-DT-1000 /SP20-MV

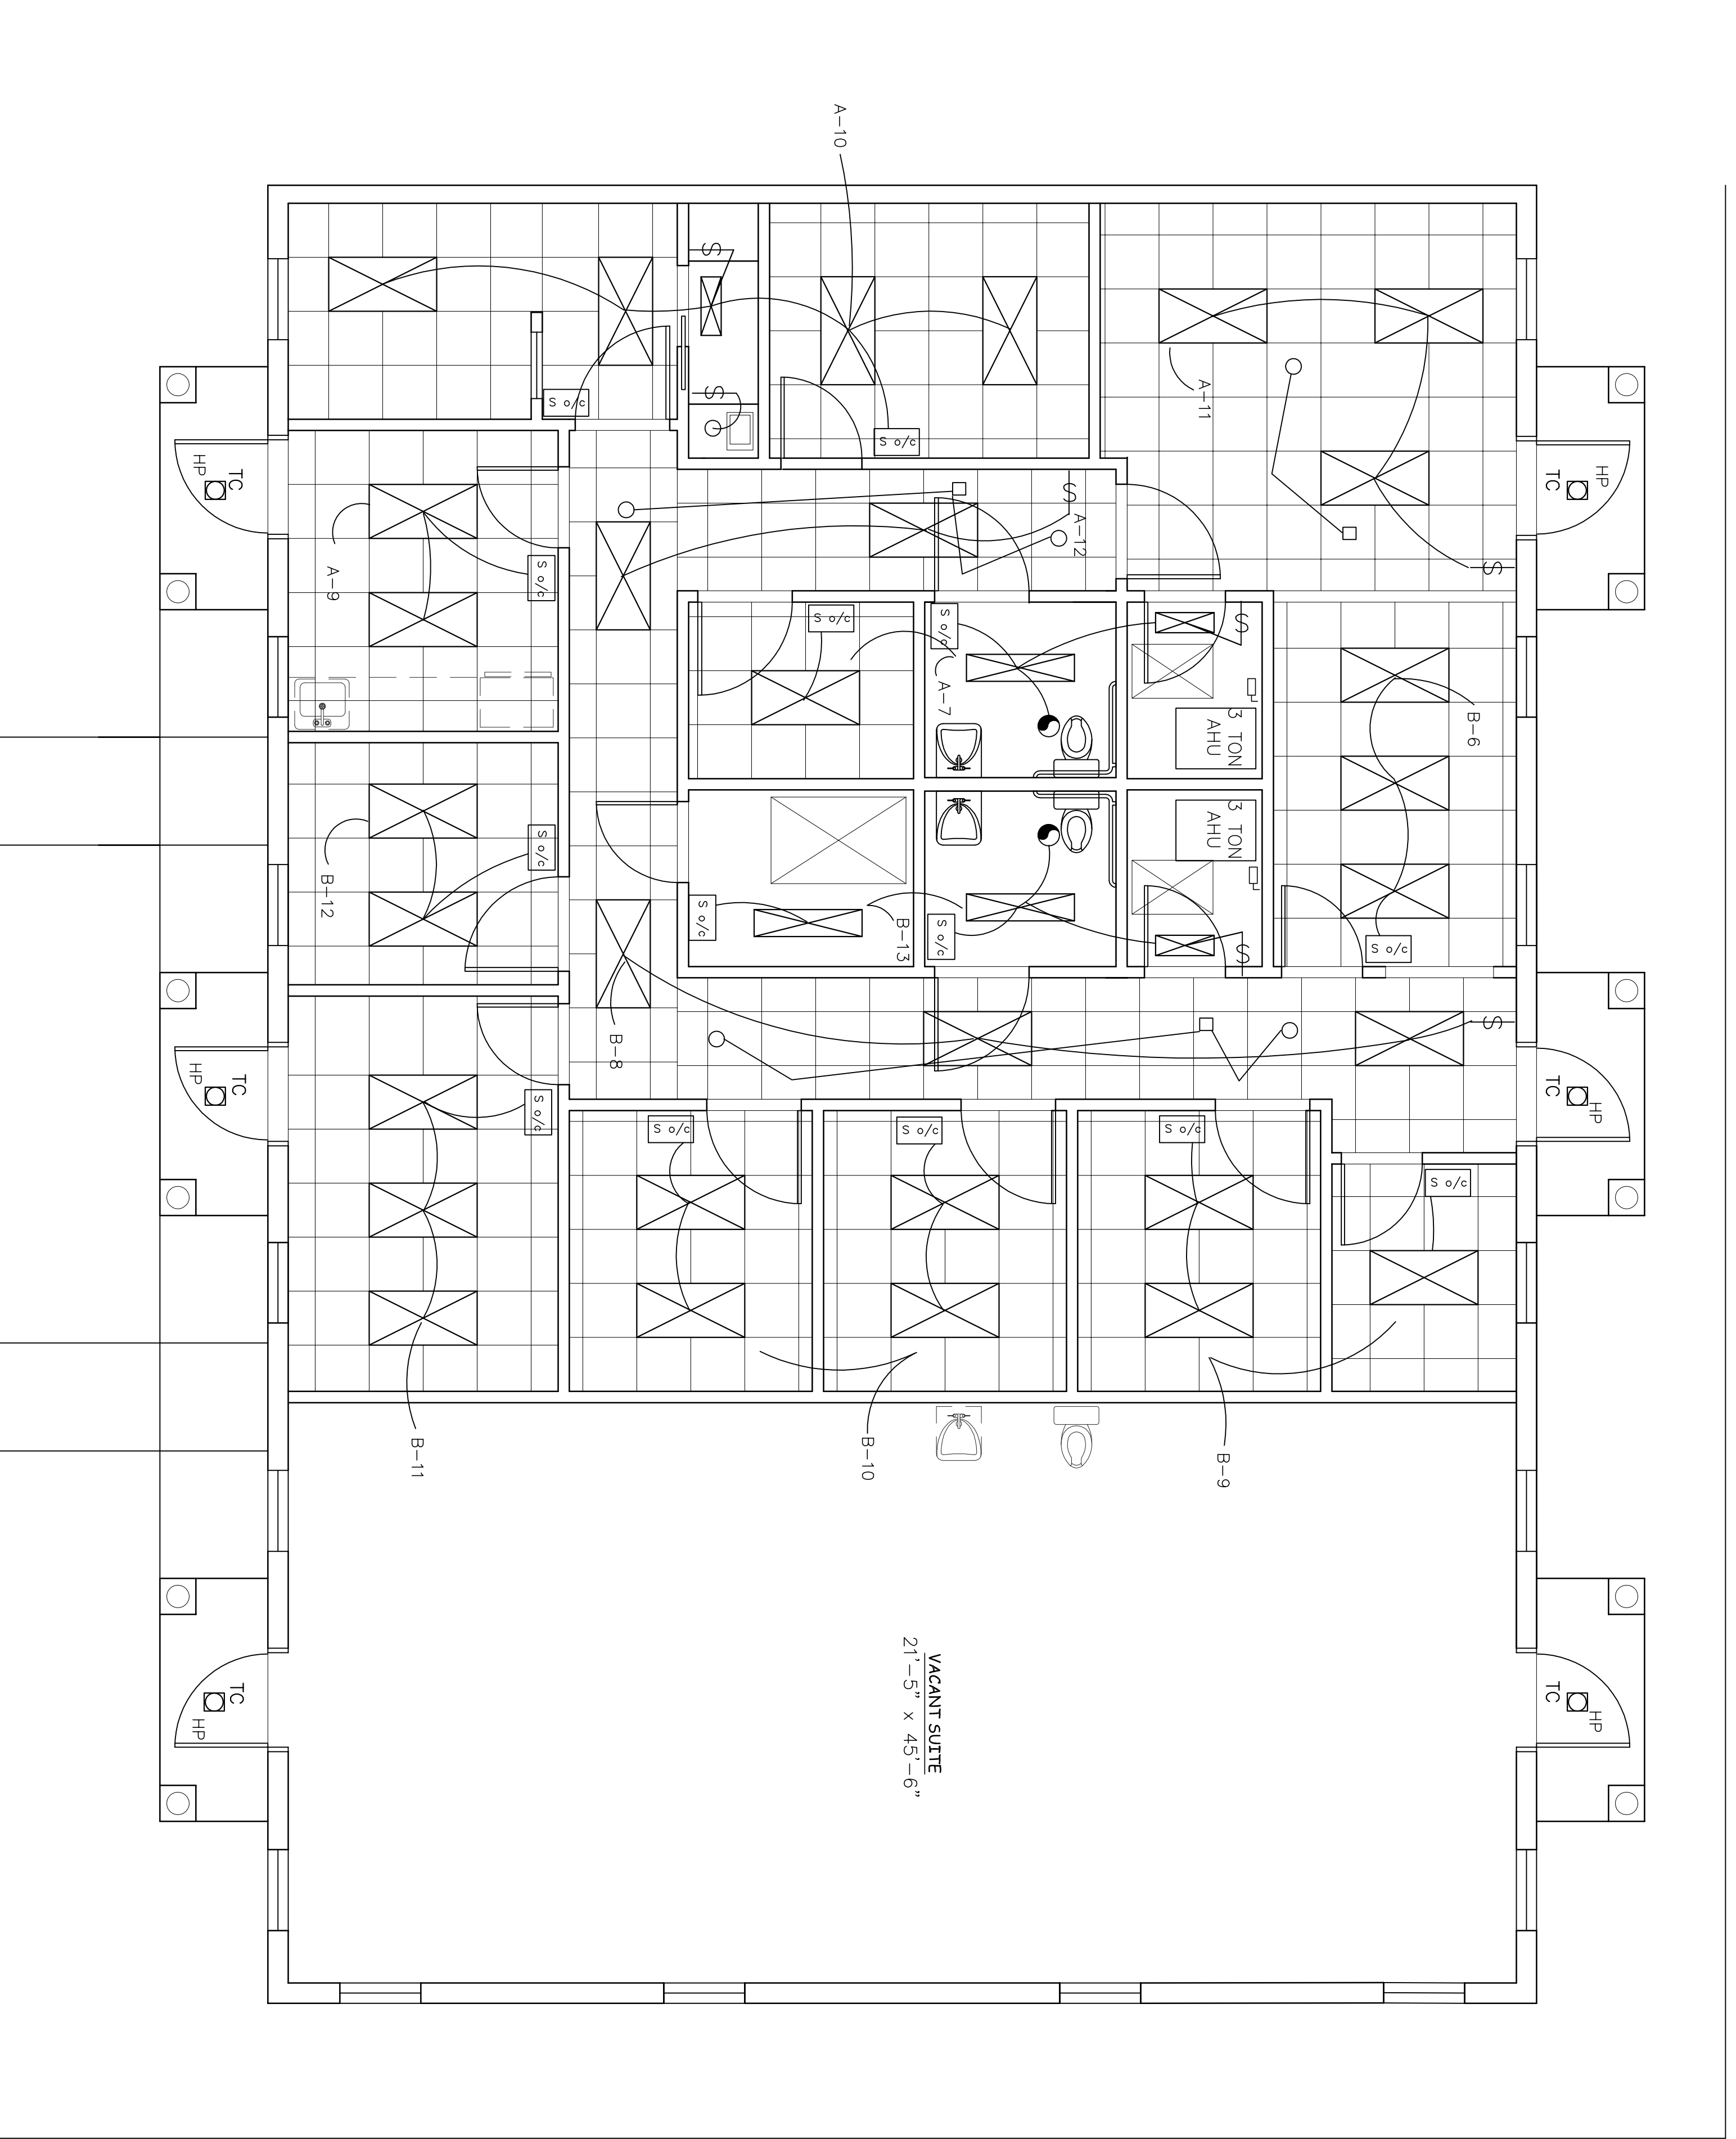


ELECTRICAL LIGHTING PLAN

SCALE : 1/4" = 1'-0"

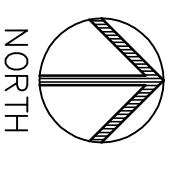

Job No. 13-19
 Date 4-28-14
 Sheet No.
E-2
 of 2

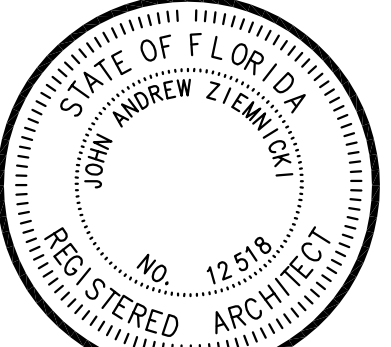

NEW BUILDING FOR:
CONSTANTINE CHIROPRACTIC
 312 7TH STREET WEST
 PALMETTO, FLORIDA



WORLD DESIGN, INC.
 4301 32nd Street West, Suite D-5
 Bradenton, Florida 34205
 NCARB CERTIFIED (941)-755-3934
 FAX (941)-756-6869
 FL AAC001570 EB 00076666 SC 888014
 John A. Ziemnicki, A.I.A.
 FL 12518 SC 3558 IL 11783 TN 23111

REVISIONS

FILE :
 © COPYRIGHT 2013 WORLD DESIGN, INC.