

SHEET NOTES

- ROOF DRAINS**
- FINAL ROOF DRAINAGE SYSTEM LAYOUT AND SIZING, INCLUDING GUTTERS AND DOWNSPOUTS, SHALL BE BY METAL BUILDING MANUFACTURER.
- ROOF VENTS**
- FINAL ROOF VENT DESIGN SHALL BE BY VENT PRODUCT MANUFACTURER. OTHER VENTILATION COMPONENTS BY METAL BUILDING MANUFACTURER.

ROOF VENT AREA

ROOF VENT NAME	COUNT	LENGHT (LF)	AREA PER LF	TOTAL AREA
RV-1	1	10'-0"	12.00 in²	120.00 in²
RV-2	1	10'-0"	12.00 in²	120.00 in²
RV-3	1	10'-0"	12.00 in²	120.00 in²
RV-4	1	10'-0"	12.00 in²	120.00 in²
RV-5	1	10'-0"	12.00 in²	120.00 in²
				600.00 in²

**EGI inc.**

Engineering Great Ideas, Inc.

1003 S Alexander Street, Suite 5  
Plant City, Florida 33563  
Tel: 813-752-7078  
FBPE Certificate of Authorization #29098



DATE: 12/12/2018 10:47:16 AM

DATE: FRANCISCO J. MORENO-ORAMA  
LICENSED ARCHITECT  
#AR99008

I HEREBY CERTIFY THAT THESE PLANS HAVE BEEN PREPARED, TO THE BEST OF MY KNOWLEDGE, IN ACCORDANCE WITH THE OF THE 2017 FLORIDA BUILDING CODE, 6TH EDITION, AND THE 2014 NATIONAL ELECTRIC CODE.

PERMIT DRAWINGS FOR:

**PALMETTO UMC ANNEX BUILDING**

5601 16TH AVE EAST CHURCH  
PALMETTO, FL 34221

OWNER: FAMILY OF GOD UNITED METHODIST

ADDRESS: 5601 16TH AVE EAST PALMETTO, FL 34221

TELEPHONE: (352) 729-6055

EMAIL: PALMETTOUMC@HOTMAIL.COM

OWNER'S REPRESENTATIVE:  
FRANK COSEGLIA, CHAIRMAN LEADERSHIP COUNCIL

REVISIONS

NO	DATE	DESCRIPTION

PROJECT NO: Project Number

FILE:

DRAWN BY: Author CHK'D BY: Checker

© 2018 ENGINEERING GREAT IDEAS, INC.


SHEET TITLE:

**ROOF PLAN**

SHEET COUNT: OF

SHEET IDENTIFICATION:

A130

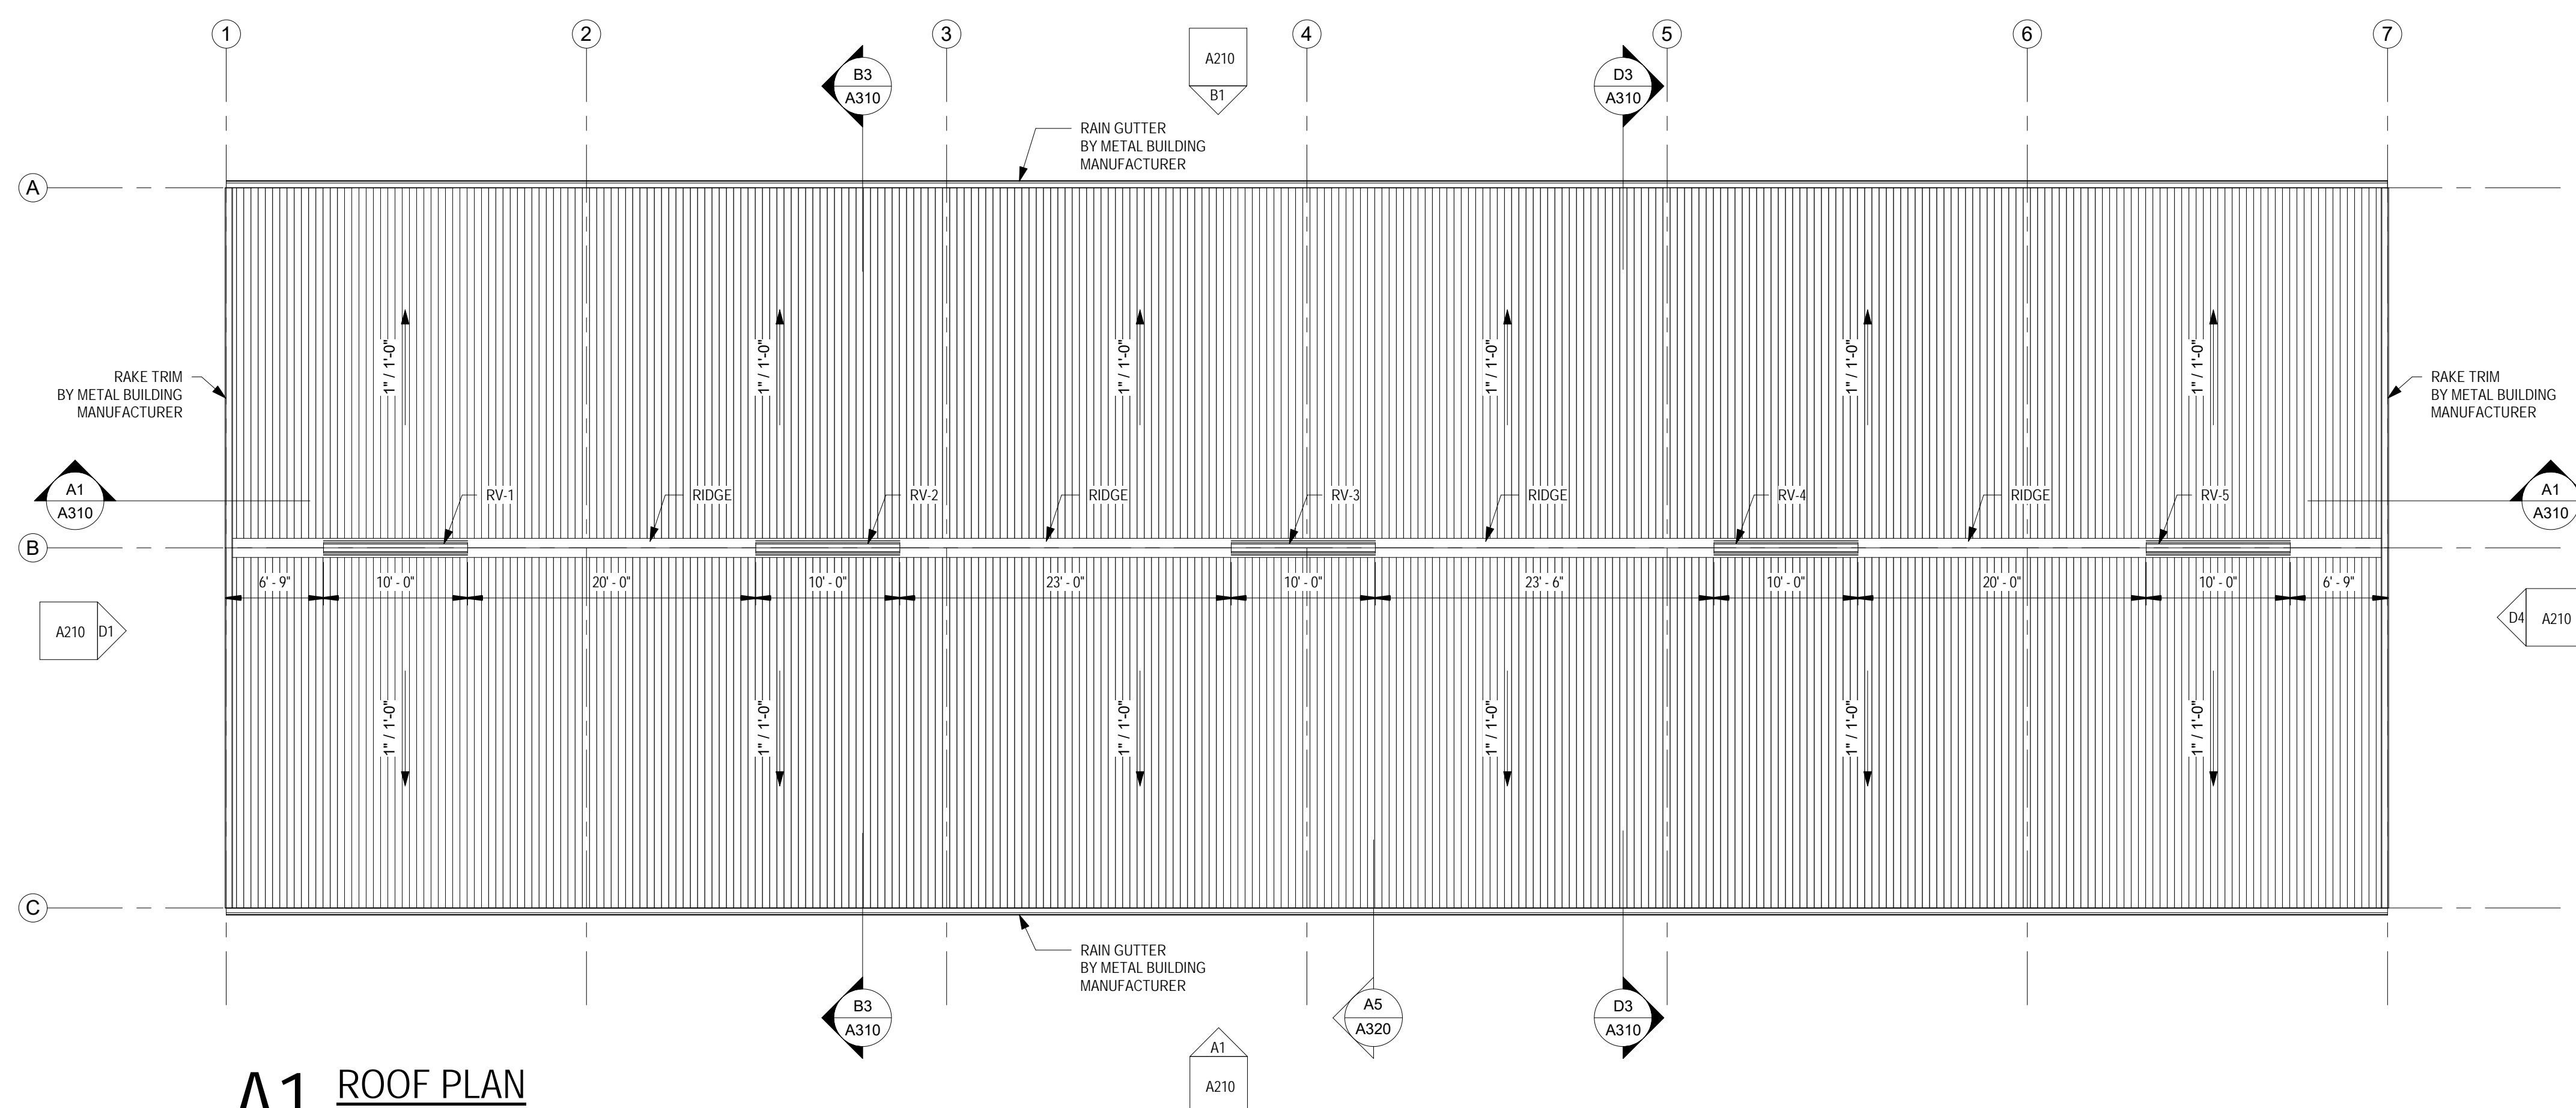

**A1 ROOF PLAN**  
SCALE: 1/8" = 1'-0"